

CAUTION: This system was designed by ReWater for a specific project that included numerous factors not found on other sites. It is not suitable for any other project and may not be used as such. It is only provided to understand how a particular type of ReWater system flows.

PROPOSED POOL  
EQUIPMENT LOCATION  
(VERIFY)

AC CONDENSING UNIT FOR  
POOL HOUSE

LINE OF PARTIAL  
BASEMENT

PROPOSED 2-STORY WITH  
PARTIAL BASEMENT  
SINGLE FAMILY DWELLING


NEW DRIVEWAY

AC CONDENSING UNITS  
FOR MAIN HOUSE


LINE OF EXISTING TO BE  
DEMOLISHED-TYPICAL

EMERGENCY GENERATOR  
15 KW MIN

GRADING PLAN  
SCALE: 1/16" = 1'-0"

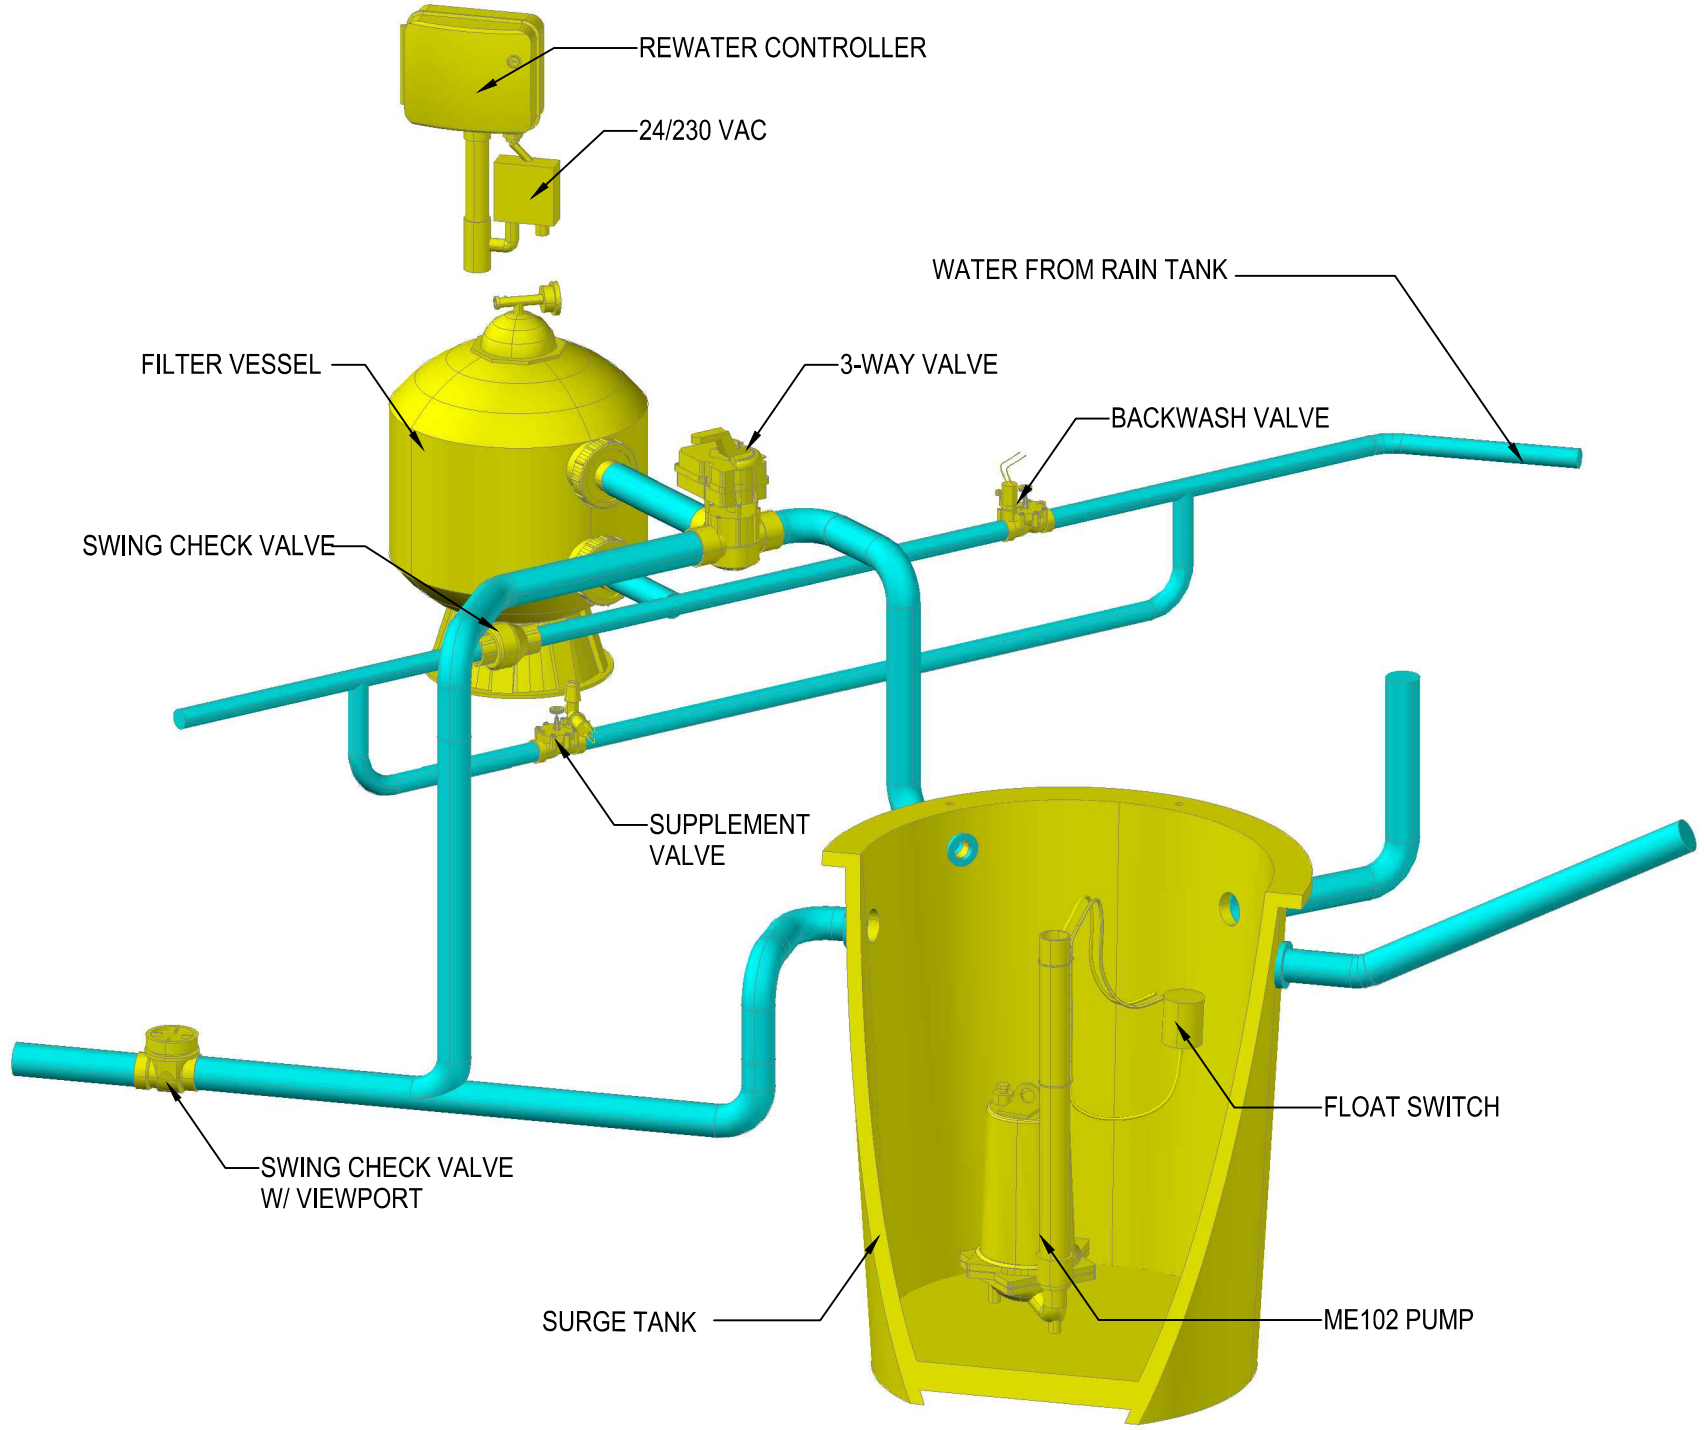

GREY WATER SYSTEM AXONOMETRIC  
SCALE: NTS

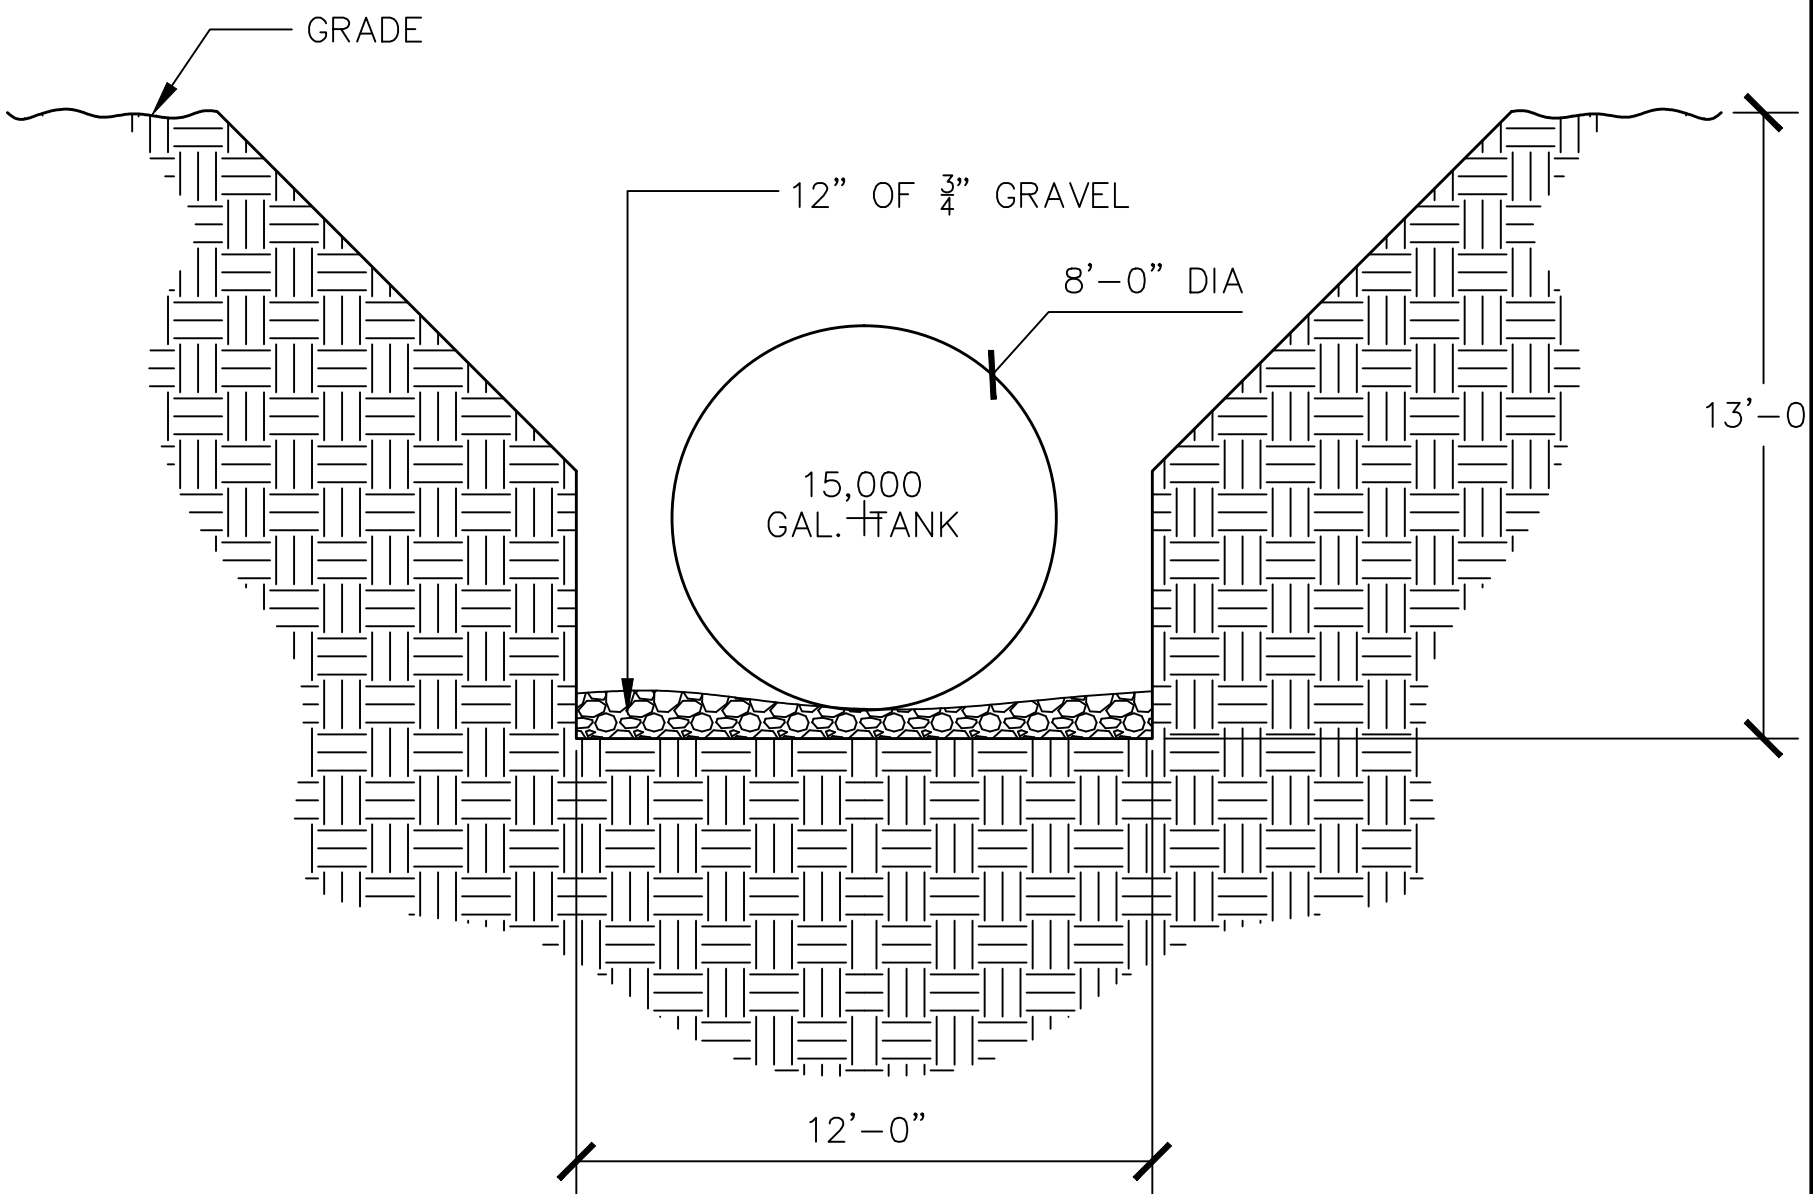

GRADING DETAIL FOR RAIN CISTERN  
SCALE: 3" = 1'-0"



LISE  
MATTHEWS  
AIA

Boomer Family Trust  
11947 Sunshine Terrace, Studio City, CA 91604

DRAWN-BY  
TJC  
JOB NO.  
0911  
DATE  
06-09-09  
FILE NAME:

APPROVED

REVISED  
07-29-09  
06-14-10  
07-09-10

SCALE:  
NTS

SHEET NO.  
RW5